


LIST OF ITEMS

ITEM NO.	DESCRIPTION	QTY.
LAUNDRY		
L01	SUS CABINET 900 X 600 X 1800mm	1
L02	FOLDABLE WALL MOUNTED IRONING BOARD 200 X 600 X 200	2
L03	ELECTRIC HAND IRON WAS235	2
L04	SUS WIRE MESH TROLLEY	1
L05	TUMBLER DRYER IMD30	2
L06	SUS TABLE W/SINK 1700 x 600 x 900	1
L07	SOAP POWDER CONTAINER W/ DETERGENT RACK BELOW	1
L08	WASHER EXTRACTOR HE30	2
L09	SUS WORK TABLE W/ CABINET (750 x 600 x 900mm)	1

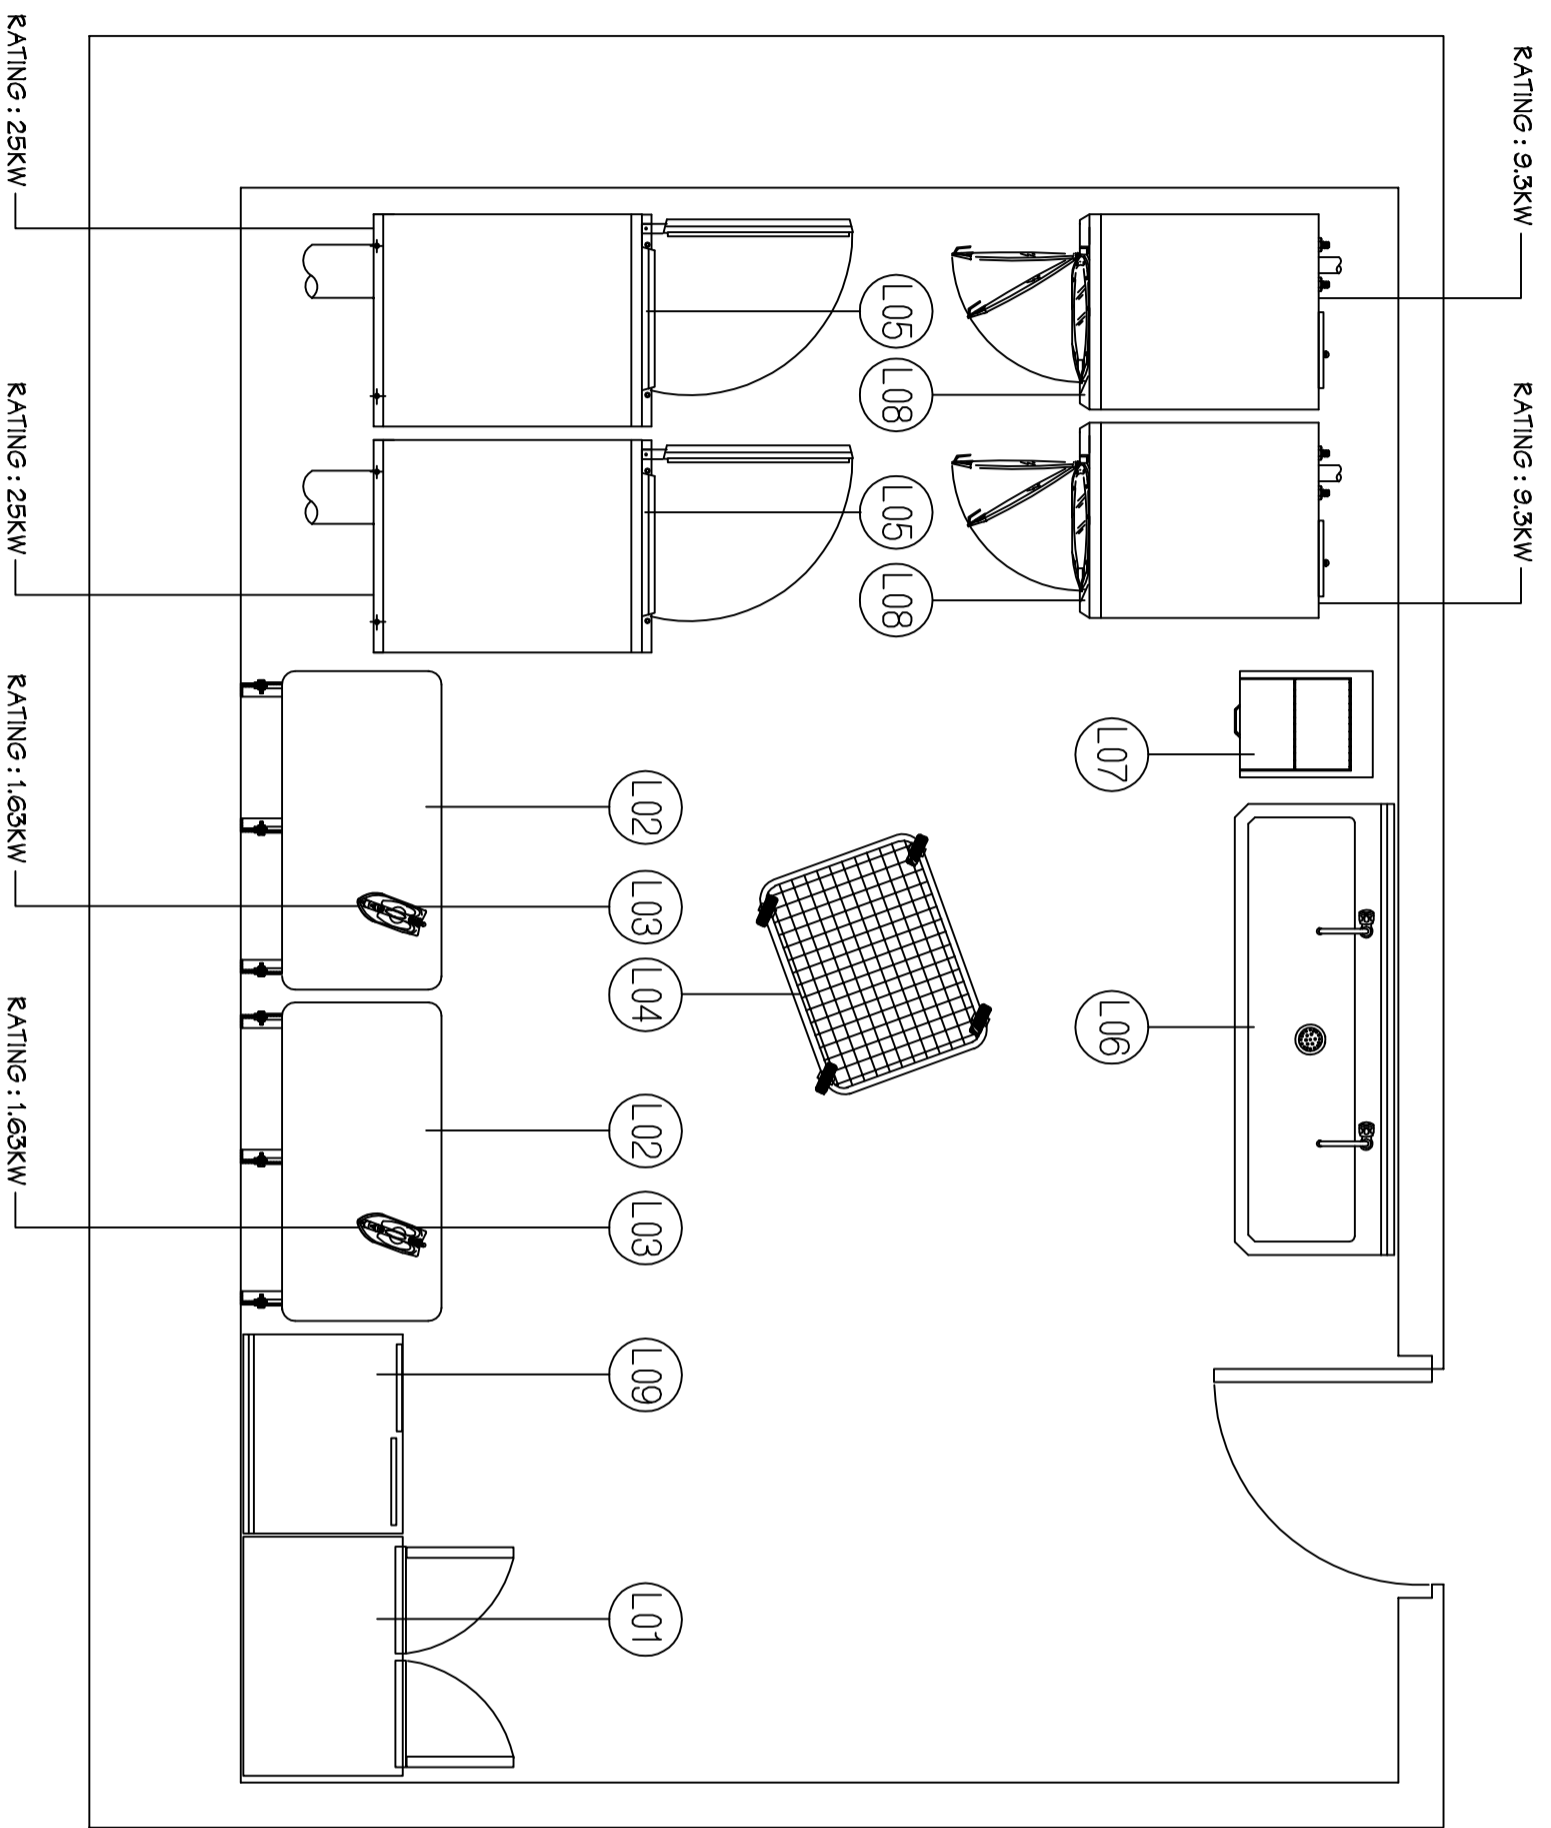

TITLE
KUMANG CLUSTER DEVELOPMANT
PROJECT LAUNDRY ELECTRICAL DETAILS

DRAWN :	VUAY	W/CODE :	S/CODE :
REVISED :	0	SCALE :	NTS
CHECKED :		SHEETS :	3 of 4
DATE :	26/07/07	DRG No. :	

GALEY ARRANGEMENT LAYOUT & EQUIPMENT DESIGN & SUPPLY BY:

KANG LI FAR EAST PTE LTD
 Planning & Electrical 00065
 Puan Singapore (911123)
 Tel: 651 6775 2166
 Fax: 651 6775 1928
 Email: klg@kangli.com.sg

ISO 9001
CERTIFIED
COMPANY